


Ground level

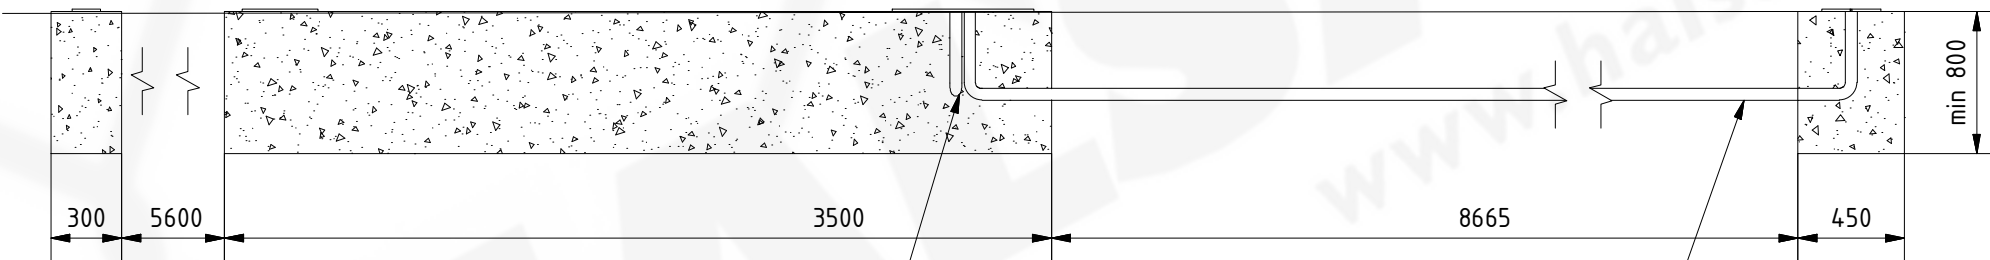

Wire pipe Ø50  
L+N+PE 230VAC 10A

Wire pipe Ø50  
photocell or alarm

Remarks:

1. All dimensions in mm.
2. Side view of foundations is from inside of property.
3. Prepare foundation with concrete class C25. Concrete must be reinforced with fibres and flat on top.
4. Expected concrete capacity 2.23m .
5. For gate installation use anchors M16x200 or longer. Anchors must be over concrete surface 80mm minimum.

Designed by I. Kłeczek	File name TFP 9000 R	Date 2017-07-04	Q-ty	Scale 1 : 32
<b>HALSANG</b>	Title THOR foundation plan 9000 right			Material
	Number TFP 9000 R	Format A4	Drawing	